



EXISTING STREET VIEW
1431 Alameda de Las Pulgas,
San Mateo, CA 94402

SCOPE OF WORK

Renovation of existing kitchen including new cabinetry, countertops, appliances, lighting, plumbing, backsplash, and new hardwood flooring installed throughout the entire 1st floor with a custom finish for a continuous look.

APPLICABLE CODES

- 2022 California Residential Code (CRC).
- 2022 California Building Code (CBC) – as referenced by CRC.
- 2022 California Plumbing Code (CPC).
- 2022 California Mechanical Code (CMC).
- 2022 California Electrical Code (CEC).
- 2022 California Energy Code (Title 24, Part 6).
- 2022 California Green Building Standards Code (CALGreen, Part 11).
- City of San Mateo municipal amendments to the California Building Standards Code.


GENERAL NOTES

THIS PLAN SET, COMBINED WITH THE BUILDING CONTRACT, PROVIDES BUILDING DETAILS FOR THE RESIDENTIAL PROJECT. THE CONTRACTOR SHALL VERIFY THAT SITE CONDITIONS ARE CONSISTENT WITH THESE PLANS BEFORE STARTING WORK. WORK NOT SPECIFICALLY DETAILED SHALL BE CONSTRUCTED TO THE SAME QUALITY AS SIMILAR WORK THAT IS DETAILED. ALL WORK SHALL BE DONE IN ACCORDANCE WITH APPLICABLE INTERNATIONAL BUILDING CODES AND LOCAL CODES. SEE ADDITIONAL NOTES CALLED OUT ON OTHER SHEETS.

VICINITY MAP



CLIENT

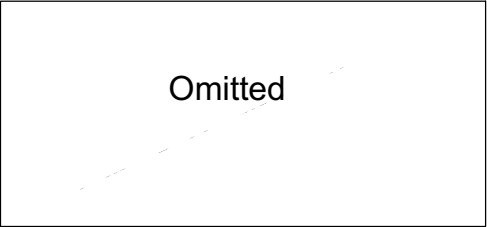

DRAWN BY *Adrian Dufour*
Adrian Dufour | Designer
Dufour Design
adrian@dufour-design.com
(650) 307-5235

INDEX OF DRAWINGS

PROJECT SUMMARY	T1
GENERAL NOTES	T2
PROPOSED KITCHEN PLAN	A1
ELEVATIONS: SINK	A2
ELEVATIONS: RANGE	A3
ELEVATIONS: RANGE HOOD	A4
ELEVATIONS: FRIDGE	A5
ELEVATIONS: FRONT OF ISLAND	A6
ELEVATIONS: PENINSULA BACK	A7
COUNTERTOP PLAN	A8
ELECTRICAL PLAN	E1
	1

SCOPE OF WORK – MIKI KITCHEN REMODEL

PROJECT LOCATION:
1431 ALAMEDA DE LAS PULGAS
SAN MATEO, CA 94402

PROJECT DESCRIPTION

RENOVATION OF EXISTING KITCHEN INCLUDING NEW CABINETRY, COUNTERTOPS, APPLIANCES, LIGHTING, PLUMBING, BACKSPLASH, AND NEW HARDWOOD FLOORING INSTALLED THROUGHOUT THE ENTIRE 1ST FLOOR WITH A CUSTOM FINISH FOR A CONTINUOUS LOOK.

DEMOLITION

- REMOVE EXISTING CABINETRY, COUNTERTOPS, BACKSPLASH TILE, FLOORING, AND SELECT WALL FINISHES AS REQUIRED.
- REMOVE EXISTING APPLIANCES SCHEDULED FOR REPLACEMENT.
- PROTECT ADJACENT SPACES DURING DEMOLITION.

CARPENTRY + CONSTRUCTION

- INSTALL NEW KITCHEN CABINETRY LAYOUT PER APPROVED PLAN SET.
- CONSTRUCT CUSTOM HOOD ENCLOSURE WITH INTEGRATED TRIM DETAILS.
- PROVIDE PANELS, FILLERS, AND SCRIBE TO ENSURE BUILT-IN APPEARANCE.
- INSTALL NEW HARDWOOD FLOORING THROUGHOUT ENTIRE 1ST FLOOR, INCLUDING SANDING, CUSTOM STAIN SELECTION, AND FINISHING FOR UNIFORM MATCH.
- INSTALL NEW BASE/SHOE MOLDING AS NEEDED.

PLUMBING

- INSTALL AND CONNECT NEW 30" APRON-FRONT SINK WITH BRUSHED-NICKEL GARBAGE DISPOSAL AIR SWITCH.
- MODIFY SUPPLY/DRAIN LINES TO MATCH NEW LAYOUT.
- RECONNECT DISHWASHER AND RELATED FIXTURES ACCORDING TO CODE.

ELECTRICAL + LIGHTING

- UPDATE ELECTRICAL AS REQUIRED TO REFLECT NEW APPLIANCE AND OUTLET LAYOUT.
- PROVIDE DEDICATED APPLIANCE CIRCUITS AS REQUIRED BY CODE.
- INSTALL NEW GFCI/USB OUTLETS AND LIGHTING PER PLANS.
- ENSURE COMPLIANCE WITH TITLE 24.

VENTILATION

- INSTALL NEW HOOD INSERT INTO CUSTOM ENCLOSURE.
- MAINTAIN OR IMPROVE EXISTING VENT DUCTING TO EXTERIOR.

COUNTERTOPS + TILE

- FABRICATE AND INSTALL NEW QUARTZ COUNTERTOPS WITH 1 1/2" FRONT OVERHANG.
- INSTALL 30" FULL-HEIGHT CLOE CREME TILE BACKSPLASH AT HOOD LOCATION.
- INSTALL BACKSPLASH TO UNDERSIDE OF UPPER CABINETS AT REMAINING LOCATIONS.

APPLIANCES

- INSTALL AND CONNECT:
- EXISTING 30" RANGE (VERIFIED FIT)
- NEW DISHWASHER
- NEW MICROWAVE DRAWER

FINISHES

- BASE CABINETS: MINGO OAK
- WALL CABINETS: IVORY
- HARDWARE: MATTE BLACK
- FIXTURES: BRUSHED NICKEL
- WALLS: PAINT TO BE SELECTED FROM APPROVED PALETTE

GENERAL REQUIREMENTS

- CONTRACTOR MUST FIELD VERIFY ALL DIMENSIONS PRIOR TO FABRICATION.
- ALL WORK TO COMPLY WITH THE 2022 CALIFORNIA BUILDING STANDARDS CODE AND CITY OF SAN MATEO REQUIREMENTS.
- CONTRACTOR RESPONSIBLE FOR PROTECTING ADJACENT FINISHES AND CLEANING UP DEBRIS.
- ANY DISCREPANCIES OR CONCEALED CONDITIONS MUST BE BROUGHT TO THE ATTENTION OF THE DESIGNER PRIOR TO PROCEEDING.

© 2025

Dufour Design

1700 El Camino Real Spt 10-7, South San Francisco, CA
(415) 745-2209 dufour-design.com

DUFOUR DESIGN

1431 Alameda de Las Pulgas
San Mateo, CA 94402

Miki Kitchen

GENERAL NOTES



DRAWN BY: Adrian Dufour, Designer DATE: 10/30/25

SHEET #

T2

PROPOSED FLOOR PLAN

1/2" = 1'

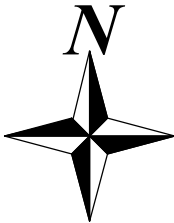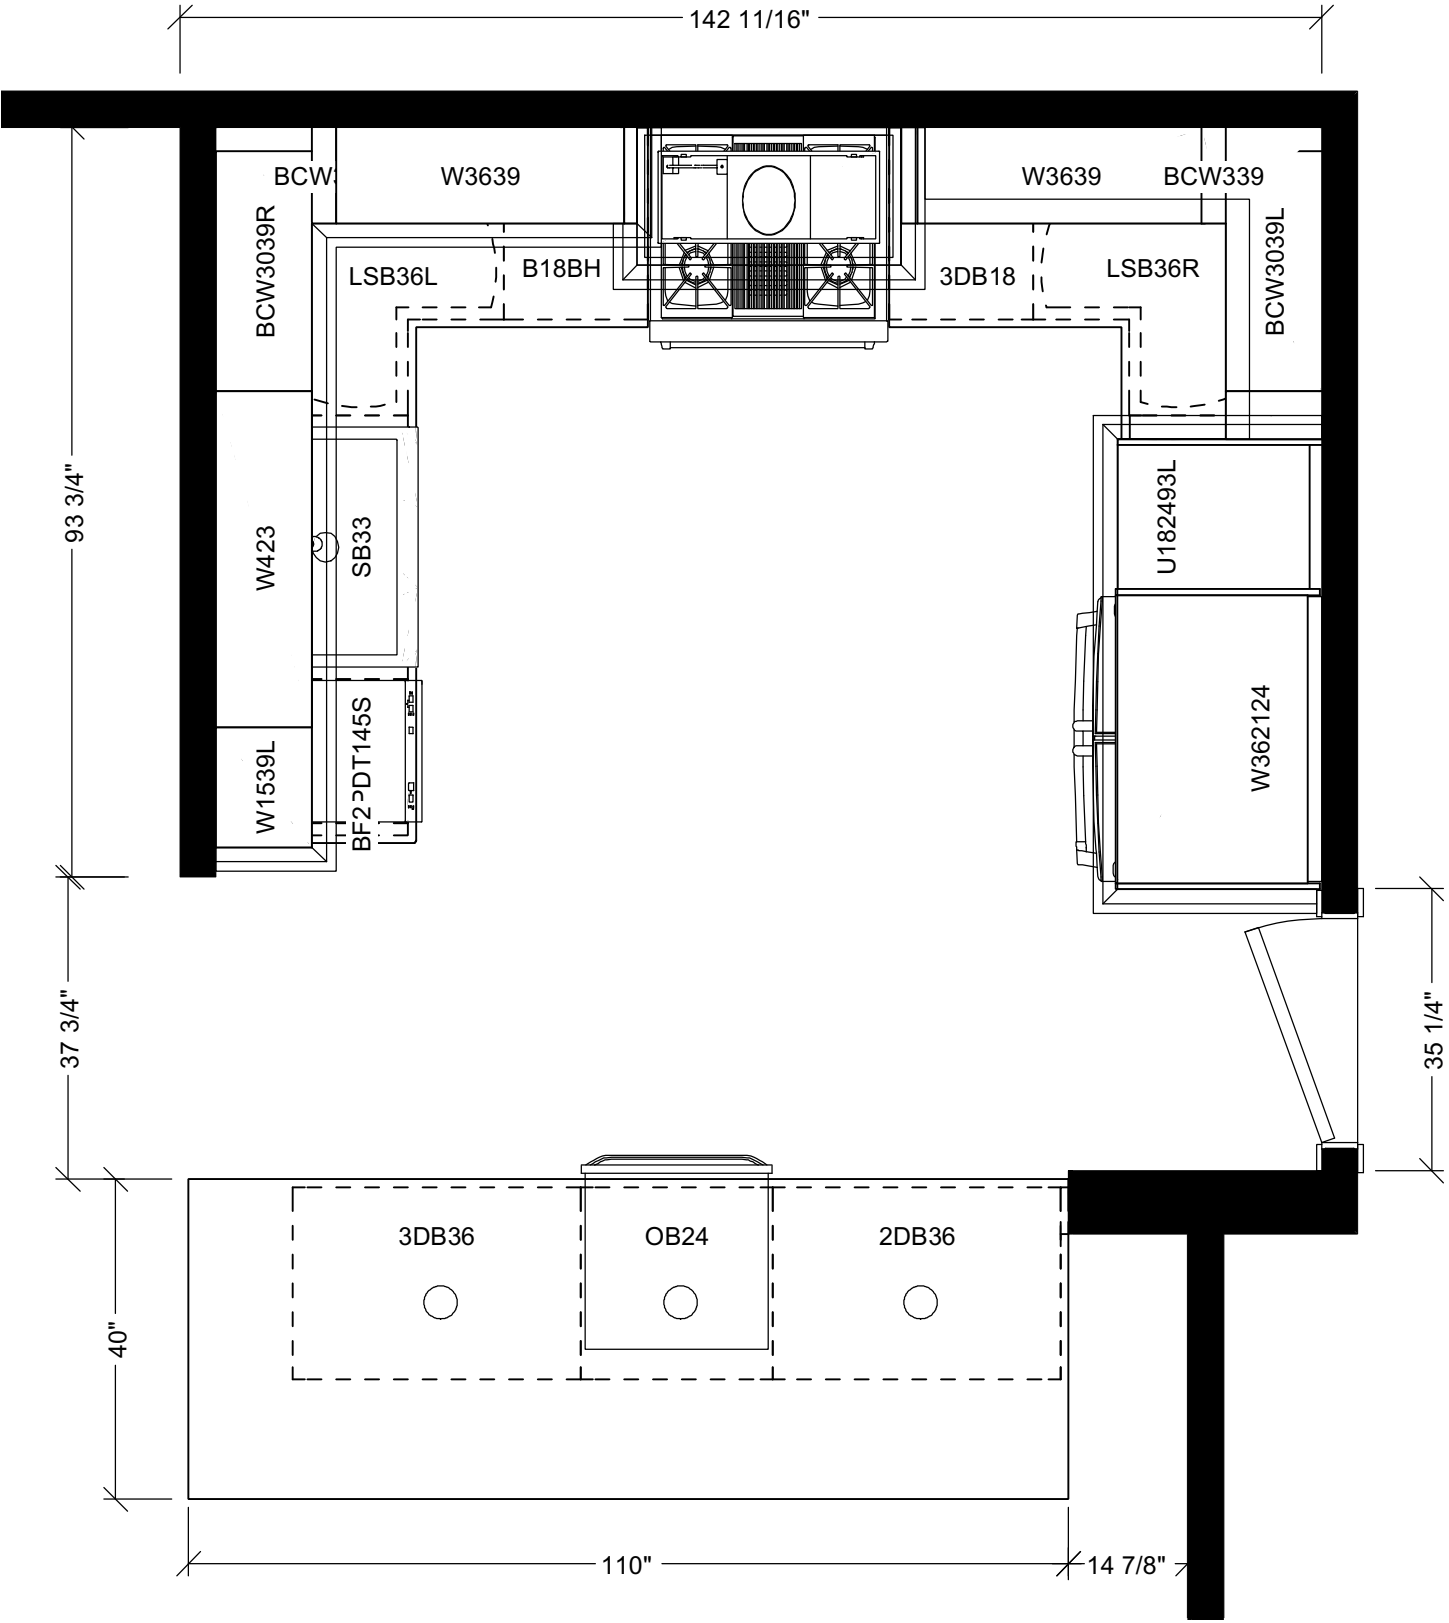

PROPOSED KITCHEN
PLAN

1431 Alameda de Las Pulgas
San Mateo, CA 94402
Miki Kitchen



Dufour Design
1700 El Camino Real Spt 10-7, South San Francisco, CA
(415) 745-2209
dufour-design.com


© 2025

DRAWN BY: Adrian Dufour, Designer
DATE: 10/30/25


SHEET #
A1

NOTE

These Tiles Must Be Installed Using A Premium Modified Thinset. Do Not Install Using Mastic

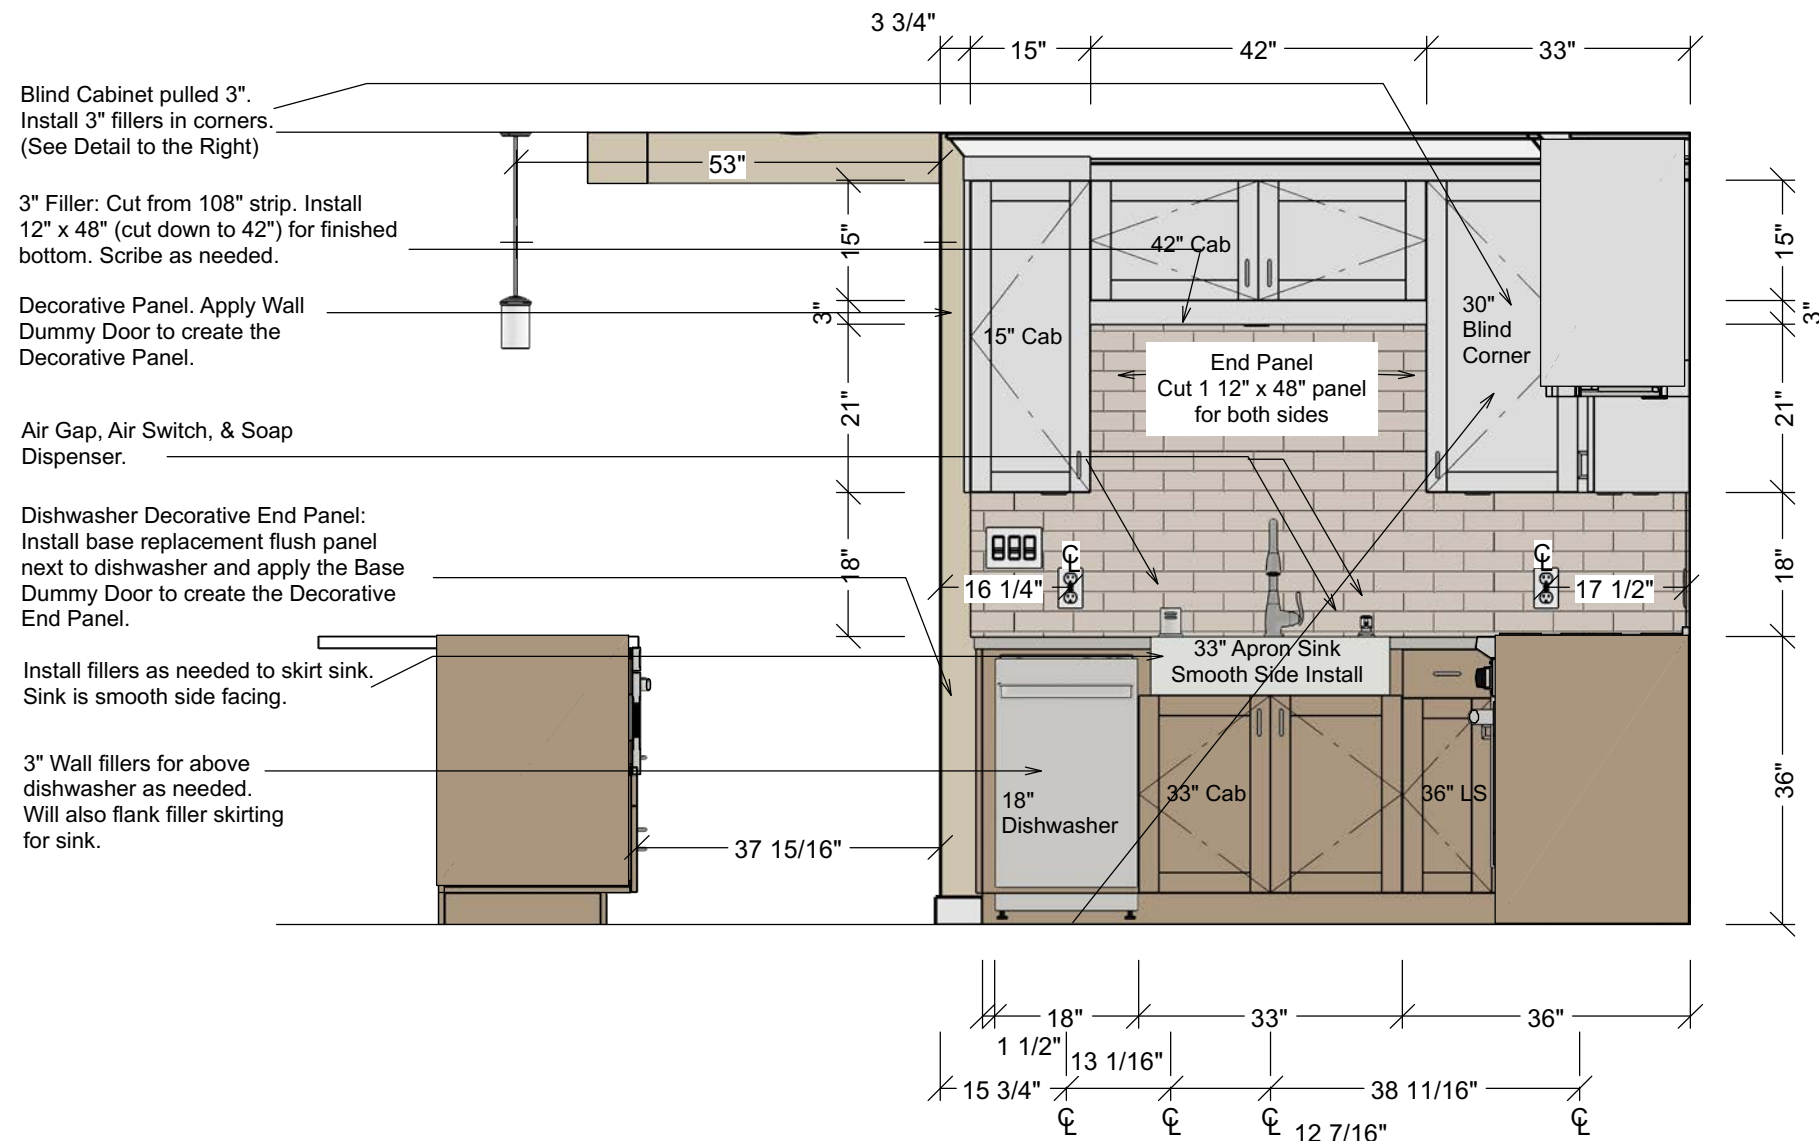


BLIND CABINET DETAILS

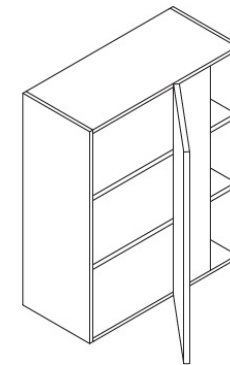



Features

- One door 14-7/8" wide, 13-5/8" opening
- Hinges on the central stile
- Cabinet can be flipped for left/right application
- Filler needs to be ordered separately
- *Two shelves
- **Three shelves

Opening Dimensions

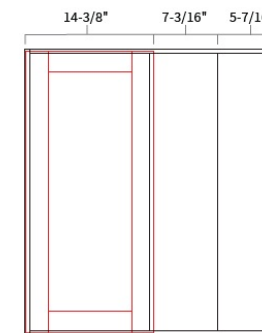


Installation Diagram

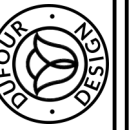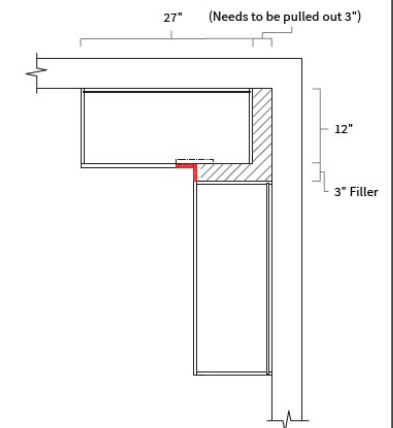

Custom Hood Box: Crown molding, box, and trim.
27" x 96" panel for the box.
3 1/2" crown molding for the hood insert frame.
4 1/2" toe kick for trim detail.
**SEE DETAIL ON NEXT PAGE

3" Fillers in both corners of 30" Blind Corner
Cabinets.
Install the cabinets 3" pulled from the wall.

Add fillers to sides of box, flush with cabinets.

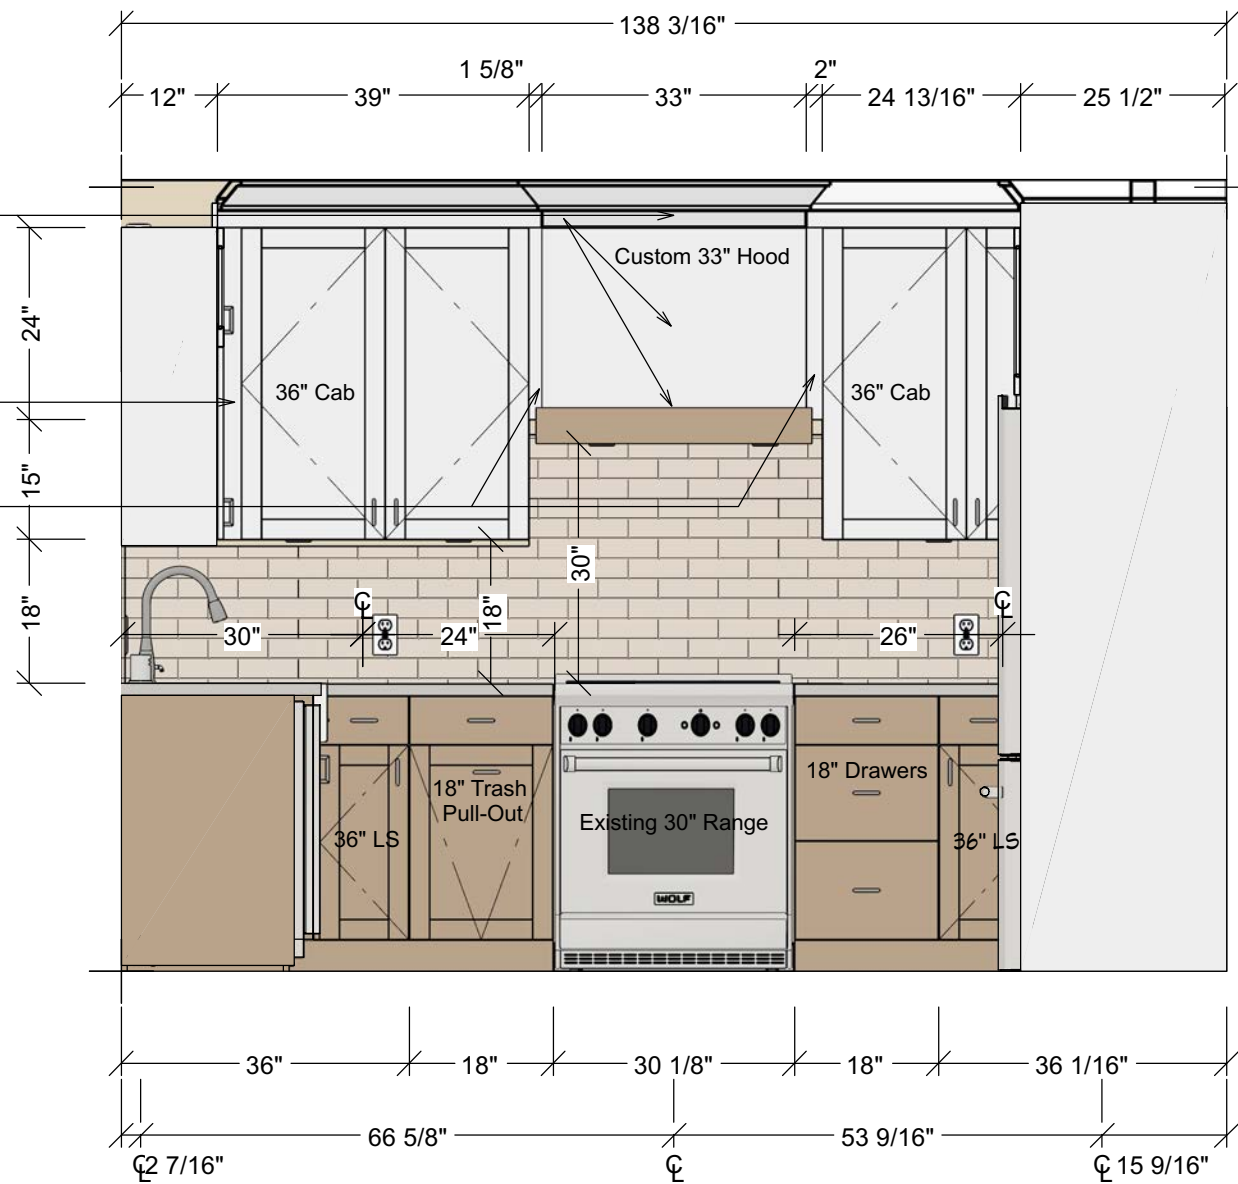

CUSTOM HOOD


1" = 1'

Hood Box: Use 96" Ivory finish panel to create the 33" front and 17.25" sides.



Box Trim: Use Mingo Oak 4.5" Toe Kick.

Hood Insert Housing: Use 3.5" Ivory crown molding and install inside the box to house the hood insert.

Hood Top: Cut down 27" x 36" panel and add blocking to create hood top. Cut a hole for vent if necessary. Vent runs sideways through the garage so may not need to cut a hole.

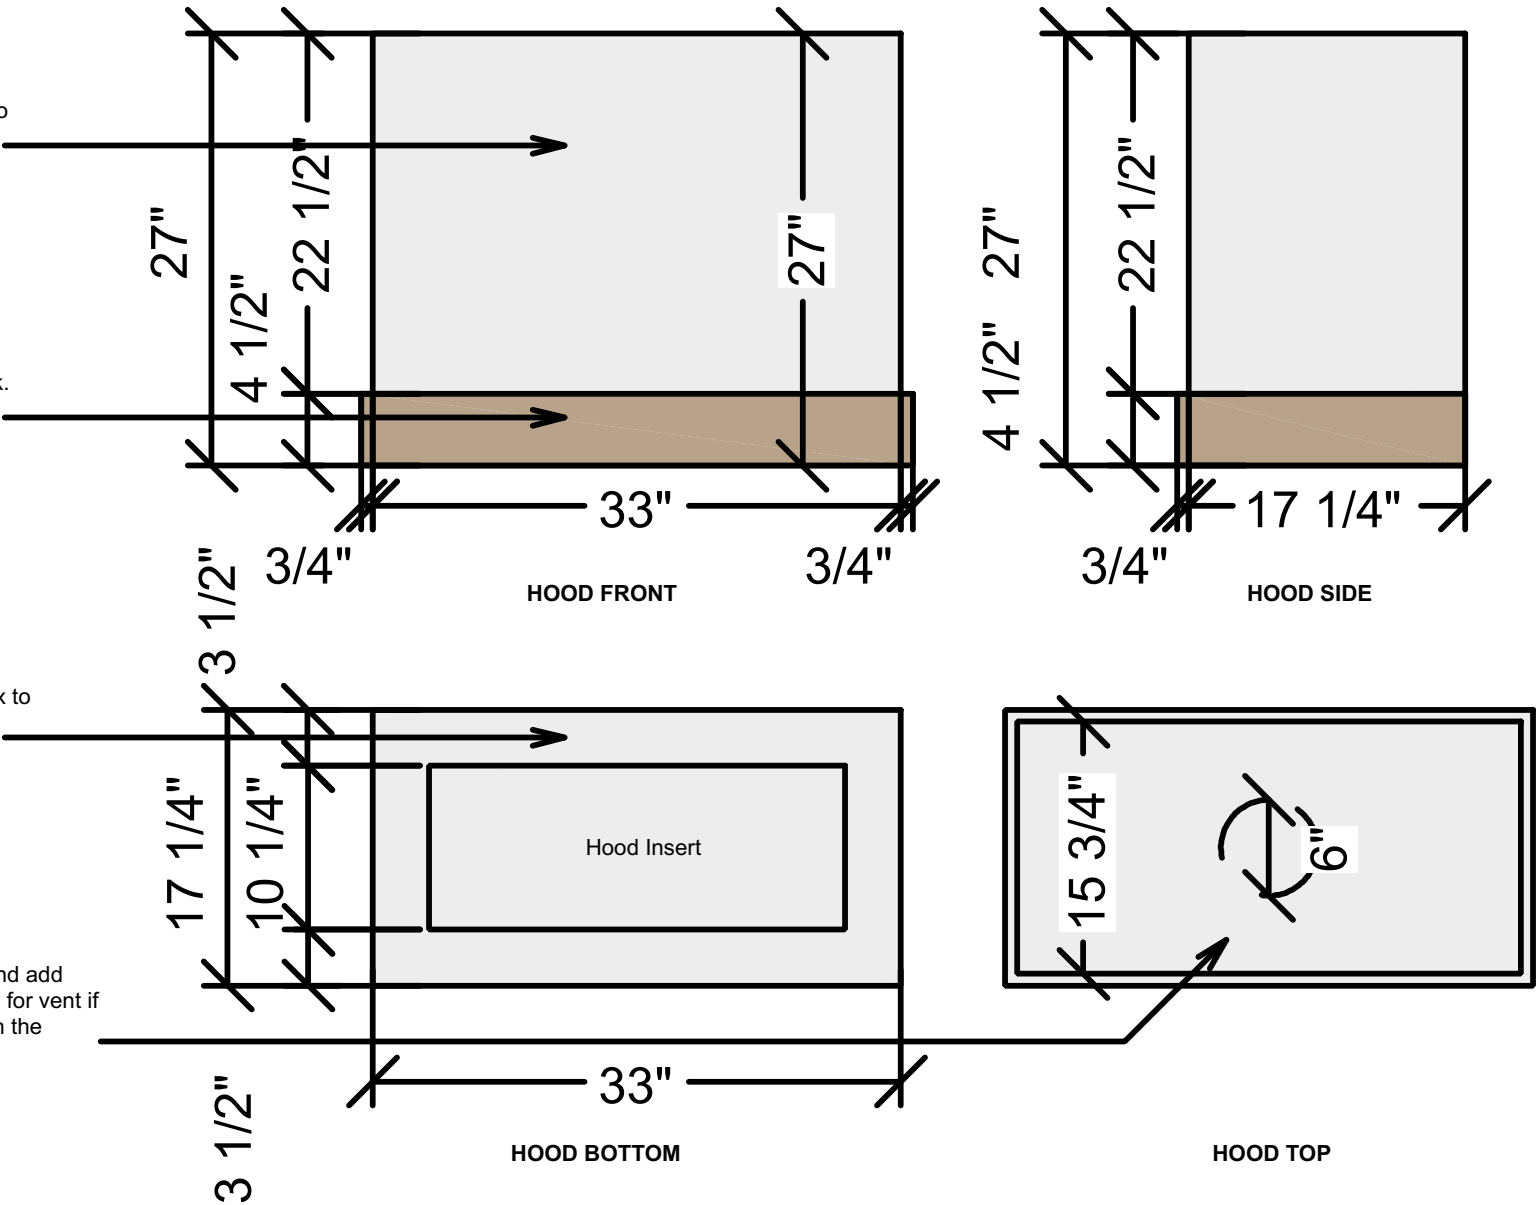


End Panels.
27"W x 96"H x 3/4"D.
Cut to 25.5" Deep.

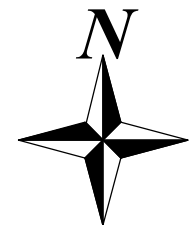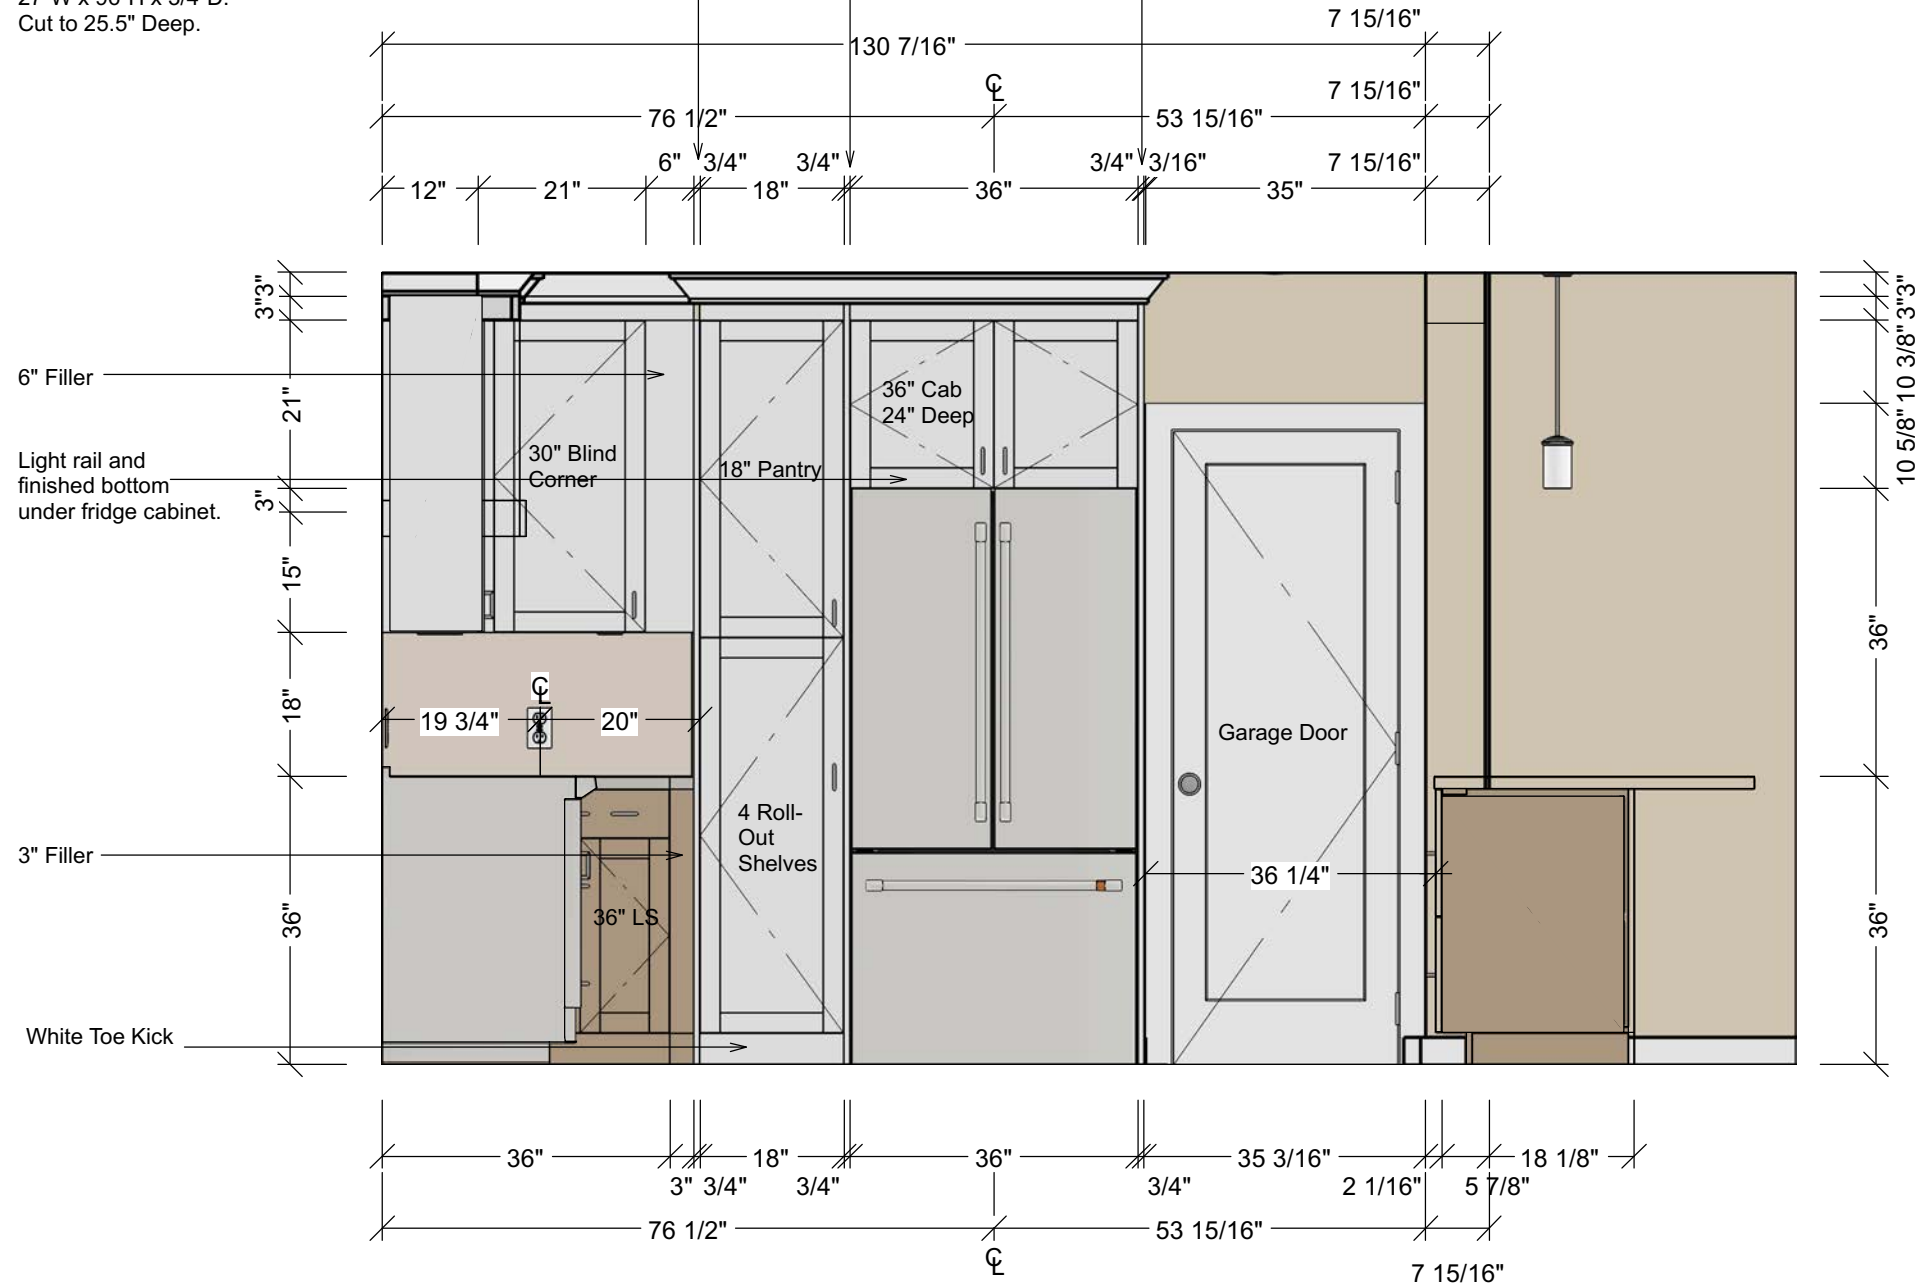



ISLAND FRONT ELEVATION

1/2" = 1'

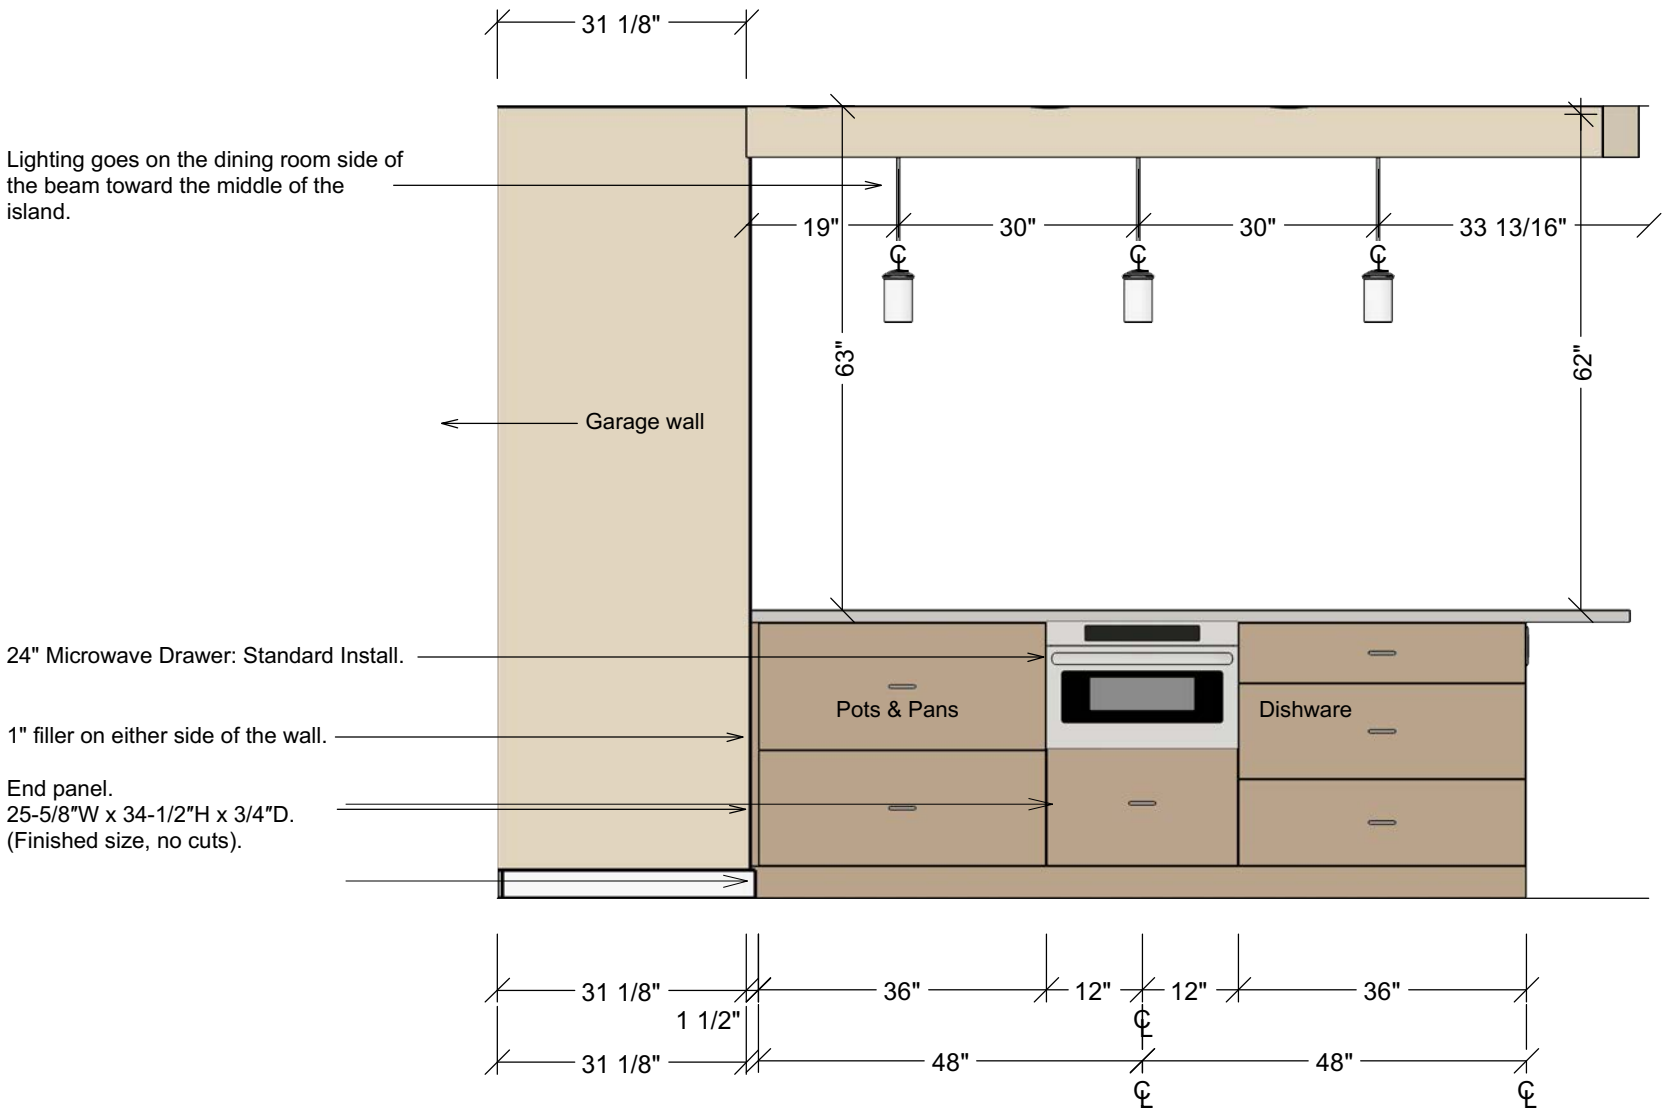

ELEVATIONS: FRONT OF ISLAND

1431 Alameda de Las Pulgas
San Mateo, CA 94402

Miki Kitchen




Dufour Design

© 2025
1700 El Camino Real Spc 10-7, South San Francisco, CA
(415) 745-2209
dufour-design.com

DRAWN BY: Adrian Dufour, Designer | DATE: 10/30/25

SHEET #
A6

E5 ISLAND BACK ELEVATION
1/2" = 1'

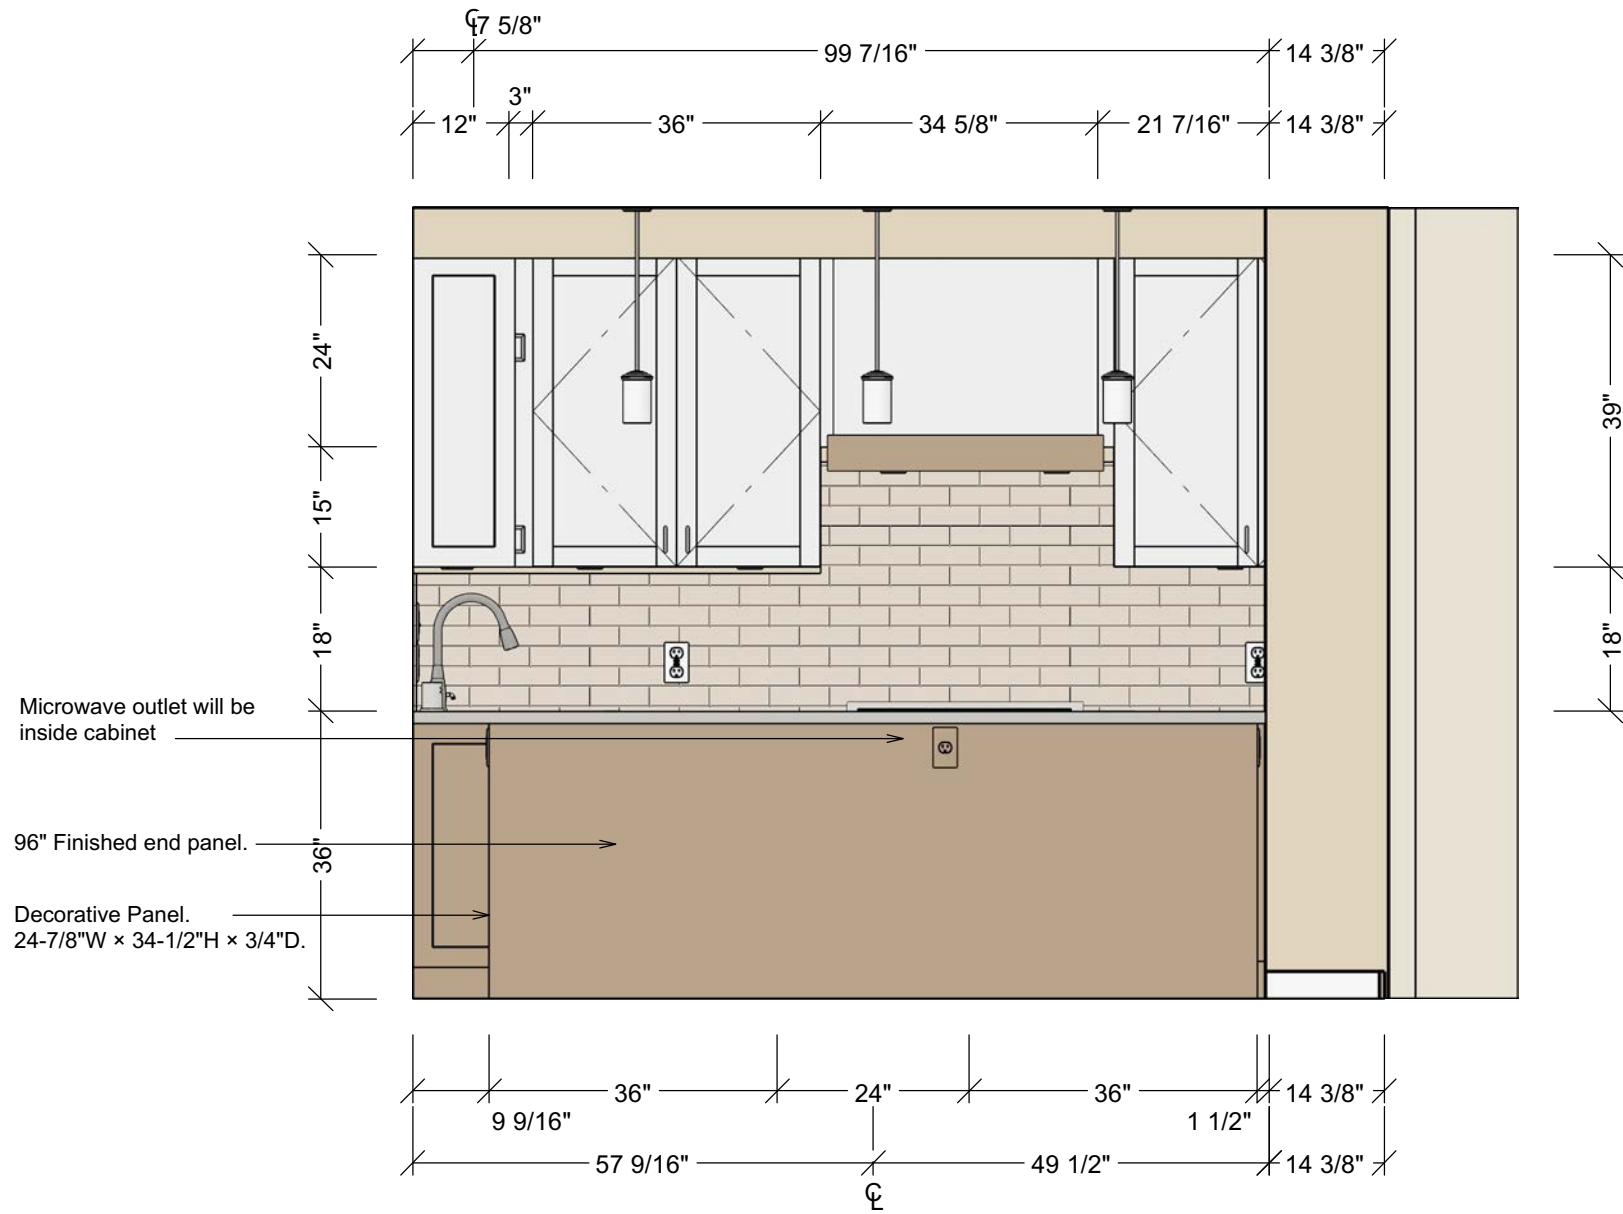

© 2025	
Dufour Design 1700 El Camino Real Spc 10-7, South San Francisco, CA (415) 745-2209 dufour-design.com	
1431 Alameda de Las Pulgas San Mateo, CA 94402 Miki Kitchen	
ELEVATIONS: PENINSULA BACK	
DRAWN BY: Adrian Dufour, Designer	DATE: 10/30/25
SHEET # A1	

MATERIALS

- Countertops: Tate Manha Quartz
- 2 25.5" D x 110" W Countertop slabs
- 1 39" x 110" Island slab

GENERAL REQUIREMENTS

- ALL DIMENSIONS ARE APPROXIMATE. CONTRACTOR AND FABRICATOR MUST FIELD-VERIFY ALL MEASUREMENTS PRIOR TO FABRICATION.
- SHOP DRAWINGS AND TEMPLATES SHALL BE SUBMITTED FOR REVIEW AND APPROVAL BEFORE CUTTING ANY MATERIAL.
- FABRICATOR TO ENSURE FIT AND ALIGNMENT WITH ALL CABINETS, APPLIANCES, WALLS, AND FINISH SURFACES.

MATERIAL + FABRICATION

- MATERIAL: QUARTZ (TATE “MANHA” OR APPROVED EQUAL), 3 CM THICKNESS, POLISHED FINISH UNLESS NOTED OTHERWISE.
- FRONT EDGE OVERHANG: 1 1/2" NOMINAL OVER CABINET FACE.
- SIDE OVERHANGS: AS NOTED ON PLAN. NO OVERHANG WHERE COUNTERTOP IS TIGHT TO WALLS OR TALL CABINETRY.
- SEAM PLACEMENT: ALIGN PER PLAN WHERE POSSIBLE, BUT FINAL LOCATION TO BE CONFIRMED IN FIELD BASED ON SLAB YIELD AND SITE CONDITIONS. SEAMS TO BE TIGHT, LEVEL, AND COLOR-MATCHED WITH APPROVED ADHESIVE.



INSTALLATION


- FABRICATOR RESPONSIBLE FOR ALL CUT-OUTS AND ACCOMMODATIONS FOR PLUMBING AND APPLIANCES, INCLUDING APRON SINK, RANGE, AND ANY FIXTURES.
- INSTALL ALL COUNTERTOPS LEVEL, WITH CONTINUOUS SUPPORT PER MANUFACTURER REQUIREMENTS.
- PROTECT ADJACENT FINISHES DURING FABRICATION AND INSTALLATION

RESPONSIBILITY

- BUILDER/INSTALLER IS RESPONSIBLE FOR CONFIRMING COMPATIBILITY WITH FIELD CONDITIONS.
- ANY DISCREPANCIES MUST BE REPORTED TO THE PROJECT MANAGER BEFORE INSTALLATION.

COUNTERTOP PLAN
1/2" = 1'

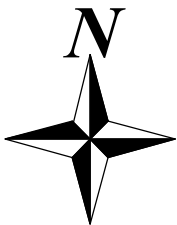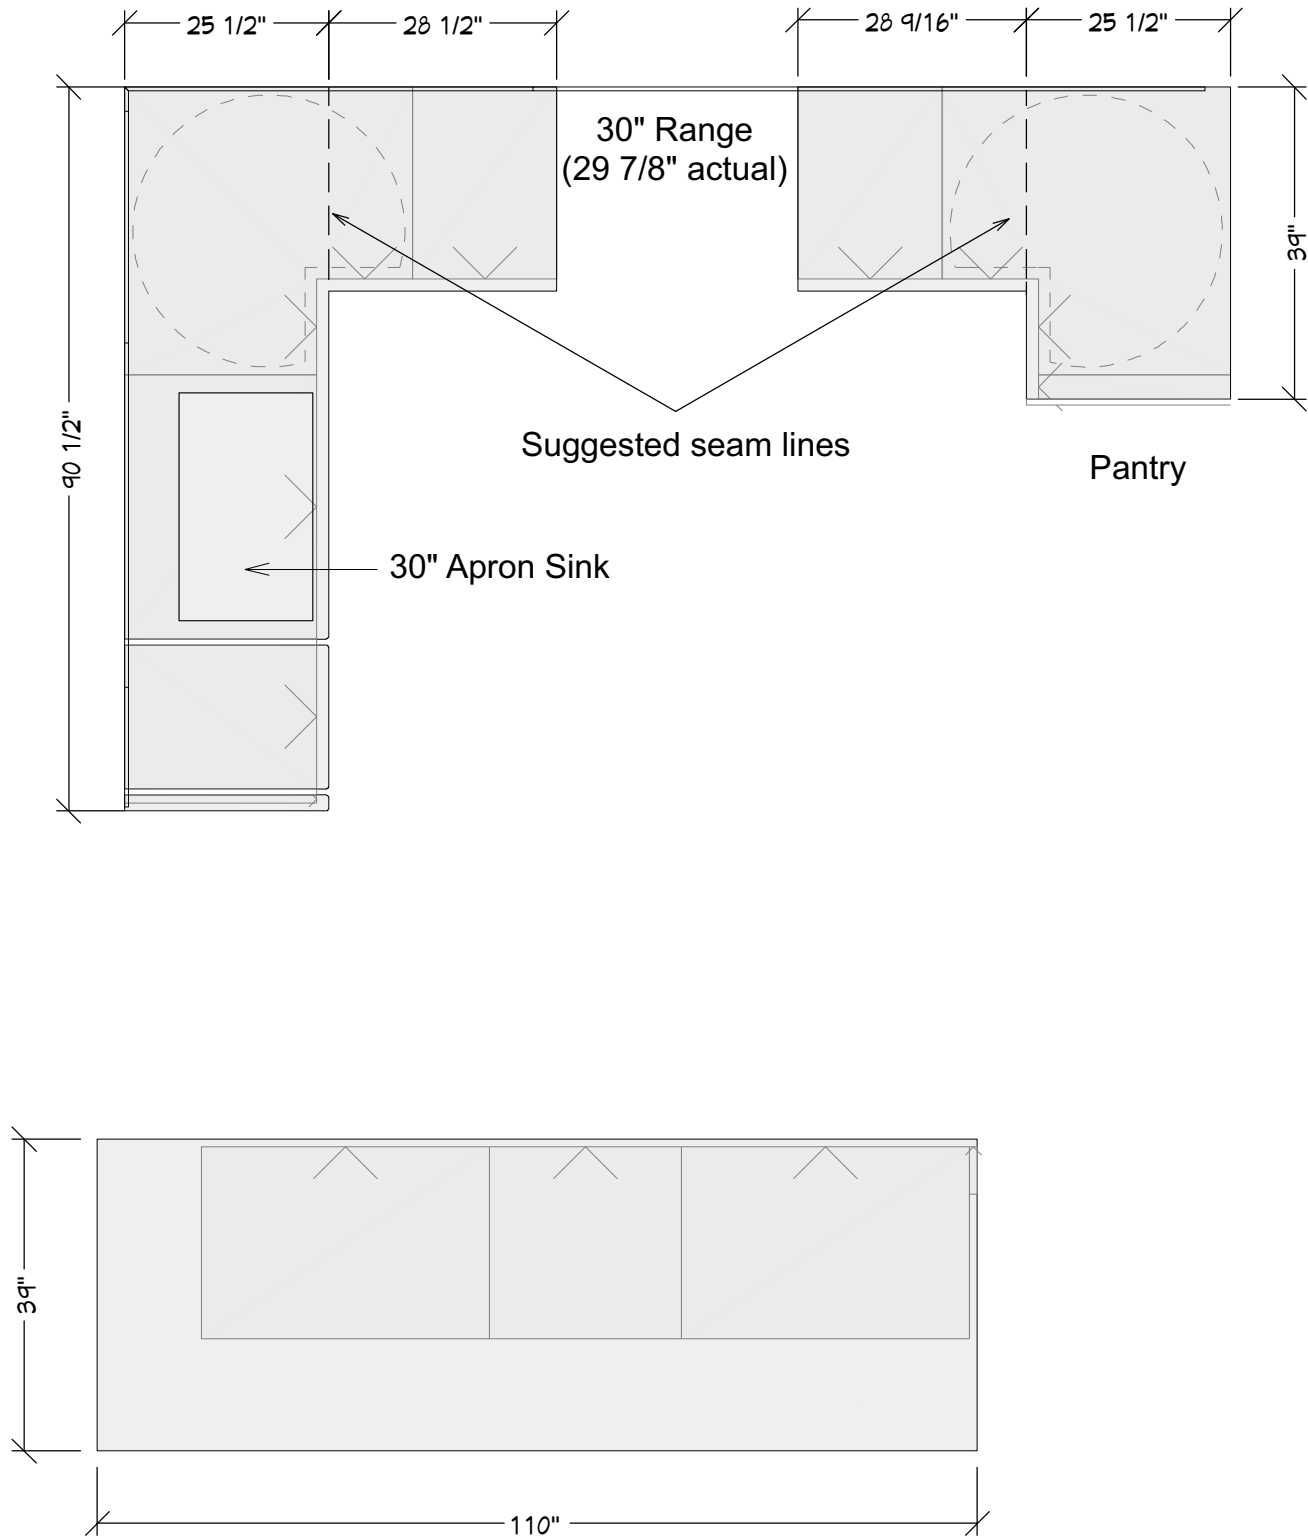


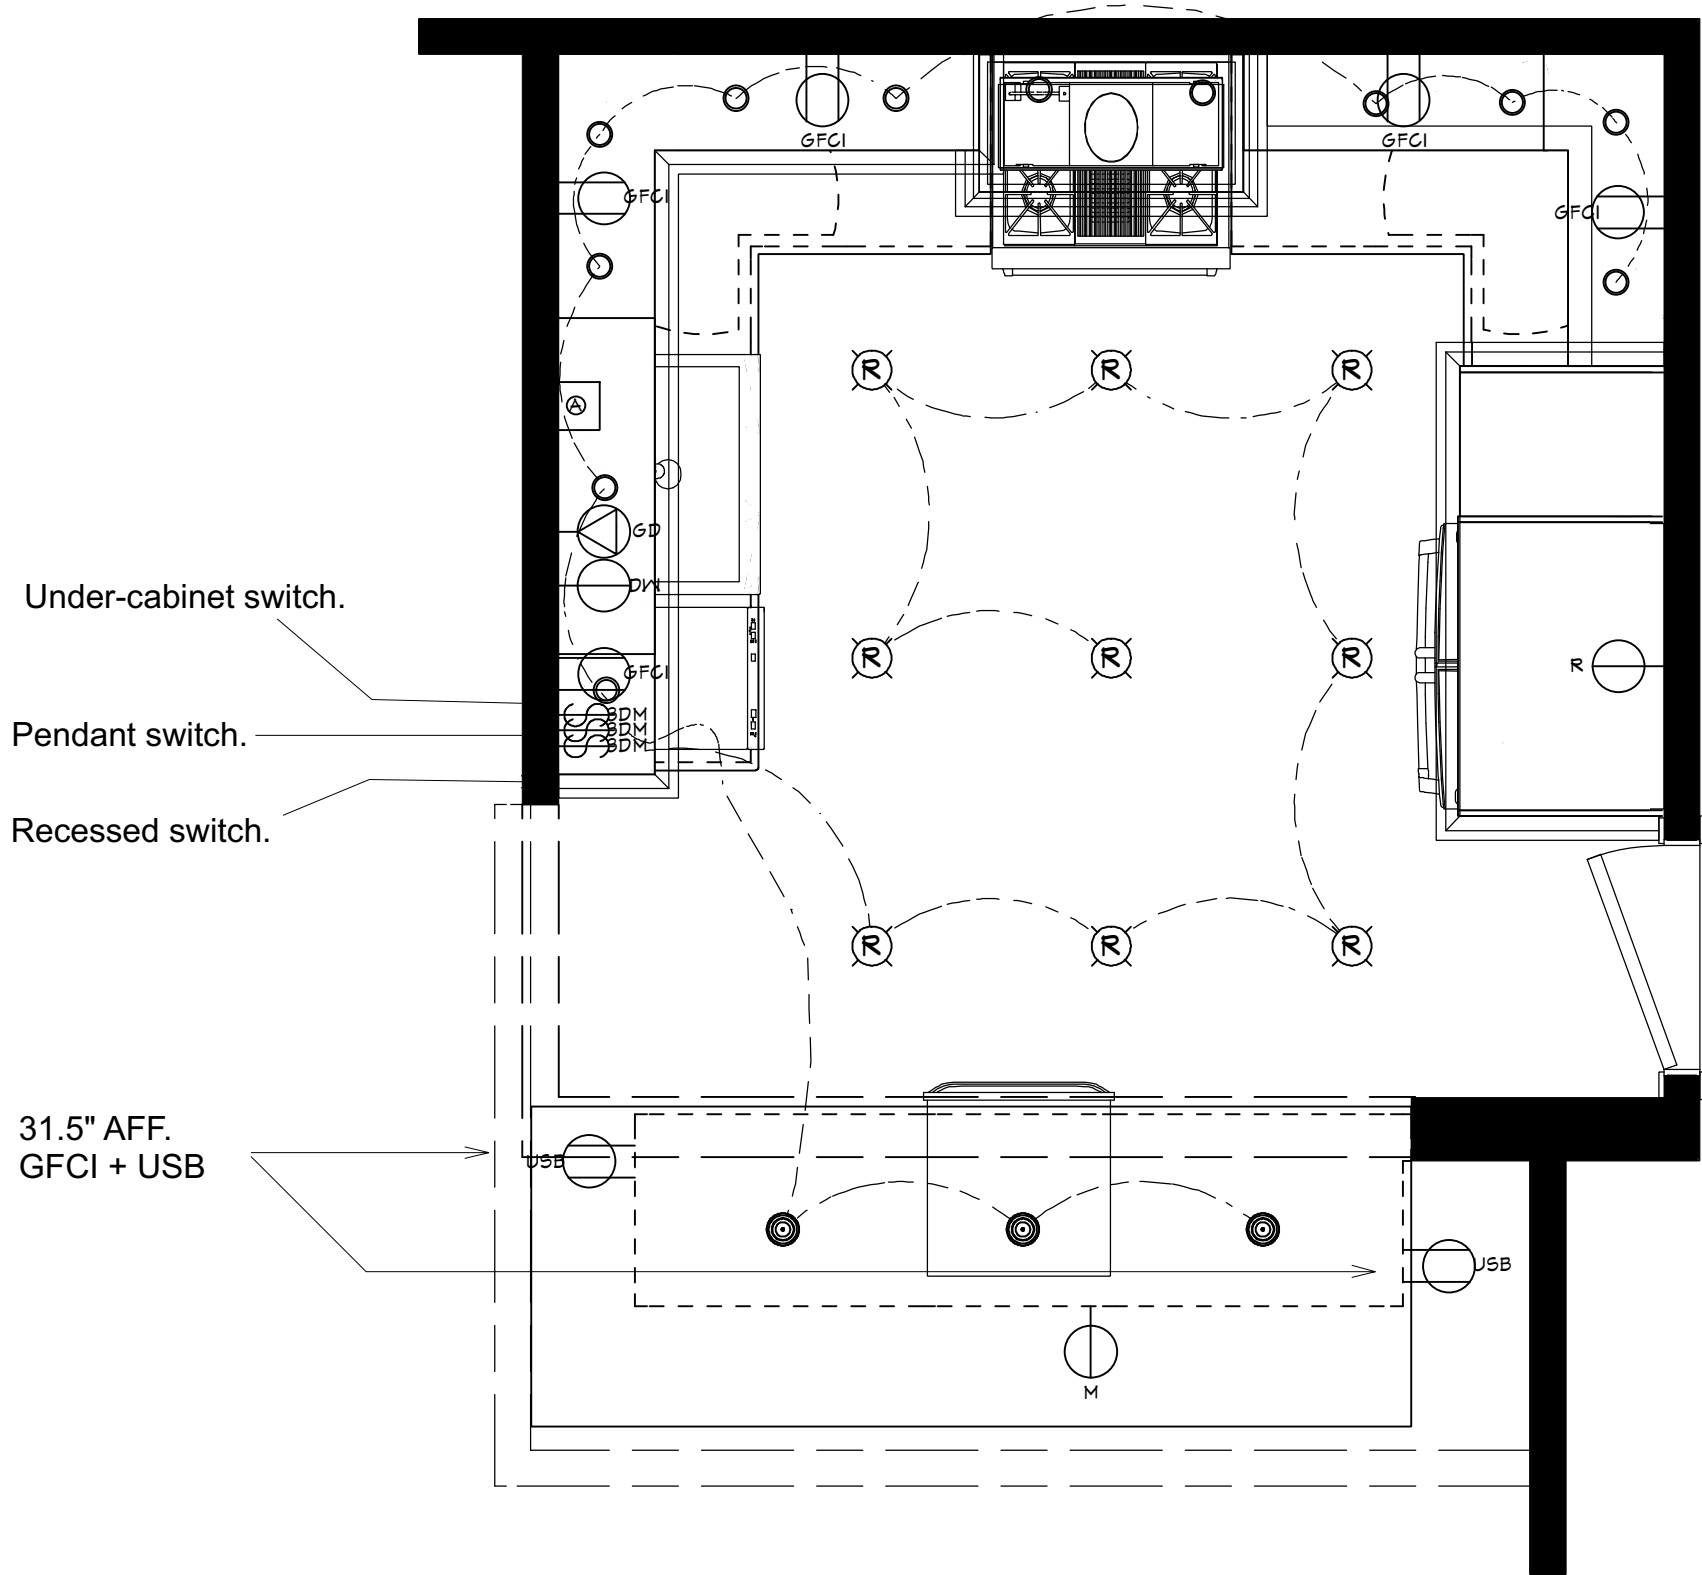

PROPOSED ELECTRICAL PLAN
1/4" = 1'

KITCHEN ELECTRICAL SCHEDULE

-  AIR SWITCH - COUNTERTOP
-  DECORATOR 2 USB CHARGER OUTLET
-  DISHWASHER
-  GFCI
-  GARBAGE DISPOSAL
-  3-WAY SLIDING DIMMER
-  [HTTPS://WWW.WAYFAIR.COM/LARK-MANOR-HAUTE-MARNE](https://www.wayfair.com/lark-manor-haute-marne)
-  MICROWAVE
-  PUCK
-  RECESSED DOWN LIGHT 4
-  REFRIGERATOR

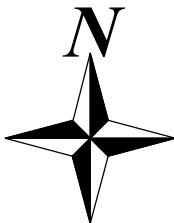

KITCHEN MATERIALS

	<u>CABINETS</u>
BASE KITCHEN CABINETS	MINGO OAK FRAMELESS CABINETS - BC2004
UPPER KITCHEN CABINETS	IVORY FRAMELESS CABINETS - BC2001
DOOR TYPE	SHAKER
MOLDING	Straight Crown 3"
CABINET PULLS	TBD
1st FLOOR FLOORING	New Hardwood Floors
COUNTERTOP	Tate Manha Quartz
COUNTERTOP ISLAND	Tate Manha Quartz
BACKSPLASH	Cloe Creme
BACKSPLASH TRIM	Cloé 0.5" x 8" Ceramic Jolly Miter Edge in Creme
GROUT	Custom Prism #382 Bone 17lb. Sanded Grout
SCHLUTER	Kerajolly KJ 3/8in Powder Coated Alum Kalahari)
	<u>PLUMBING</u>
KITCHEN SINK	Ceramic White 30 in. Farmhouse Single Bowl Workstation Apron Front Kitchen Sink with Bottom Grid and Cutting Board
KITCHEN FAUCET	Adler Touchless Single-Handle Pull-Down Sprayer Kitchen Faucet with MotionSense Wave in Spot Resist Stainless
SOAP DISPENSER	Countertop Deck-Mount Metal Soap and Lotion Dispenser in Brushed Nickel
AIR GAP	8.67 in. x 2.28 in. x 1.8 in. Dishwasher Air Gap Cover in Brushed Nickel
GARBAGE DISPOSAL	Prep Series 1/2 HP Continuous Feed Garbage Disposal with Power Cord and Universal Mount
AIR SWITCH	Brushed Nickel Garbage Disposal Kitchen Air Switch Kit
	<u>APPLIANCES</u>
REFRIGERATOR	Existing Bosch Fridge 800 Series
RANGE	Existing GE Fridge 36" Gas Range Slide-In
DISHWASHER	Bosch 800 Series 18 in. ADA Compact Top Control Dishwasher in Stainless Steel with Stainless Steel Tub and 3rd Rack, 42 dBA
HOOD	Range Hood Insert/Built-In 30 in. Ultra Quiet Powerful Suction Stainless Steel Ducted Kitchen Vent Hood with LED Lights
MICROWAVE	GE Profile™ Microwave Drawer Oven